



Office of General Services

DESIGN & CONSTRUCTION GROUP
THE GOVERNOR NELSON A. ROCKEFELLER
EMPIRE STATE PLAZA
ALBANY, NY 12242

ADDENDUM NO. 1 TO PROJECT NO. 47164

CONSTRUCTION AND ELECTRICAL WORK PROVIDE FOUNDATION REMEDIATION AND CONCRETE REPAIR CONKLINGVILLE DAM 233 COUNTY ROUTE 8 HADLEY, NEW YORK

July 13, 2026

 

NOTE: This Addendum forms a part of the Contract Documents. Insert it in the Project Manual. Acknowledge receipt of this Addendum in the space provided on the Bid Form.
--


CONSTRUCTION DRAWINGS

1. Revised Drawings:
 - a. Drawing Nos. C-716 and S-791 noted Addendum #1, dated 7/13/2026, accompanies this Addendum and supersedes the same numbered previously issued drawings.


END OF ADDENDUM

Brady M. Sherlock, P.E.
Director, Division of Design
Design & Construction

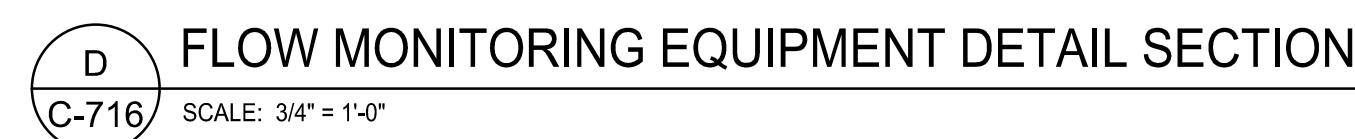

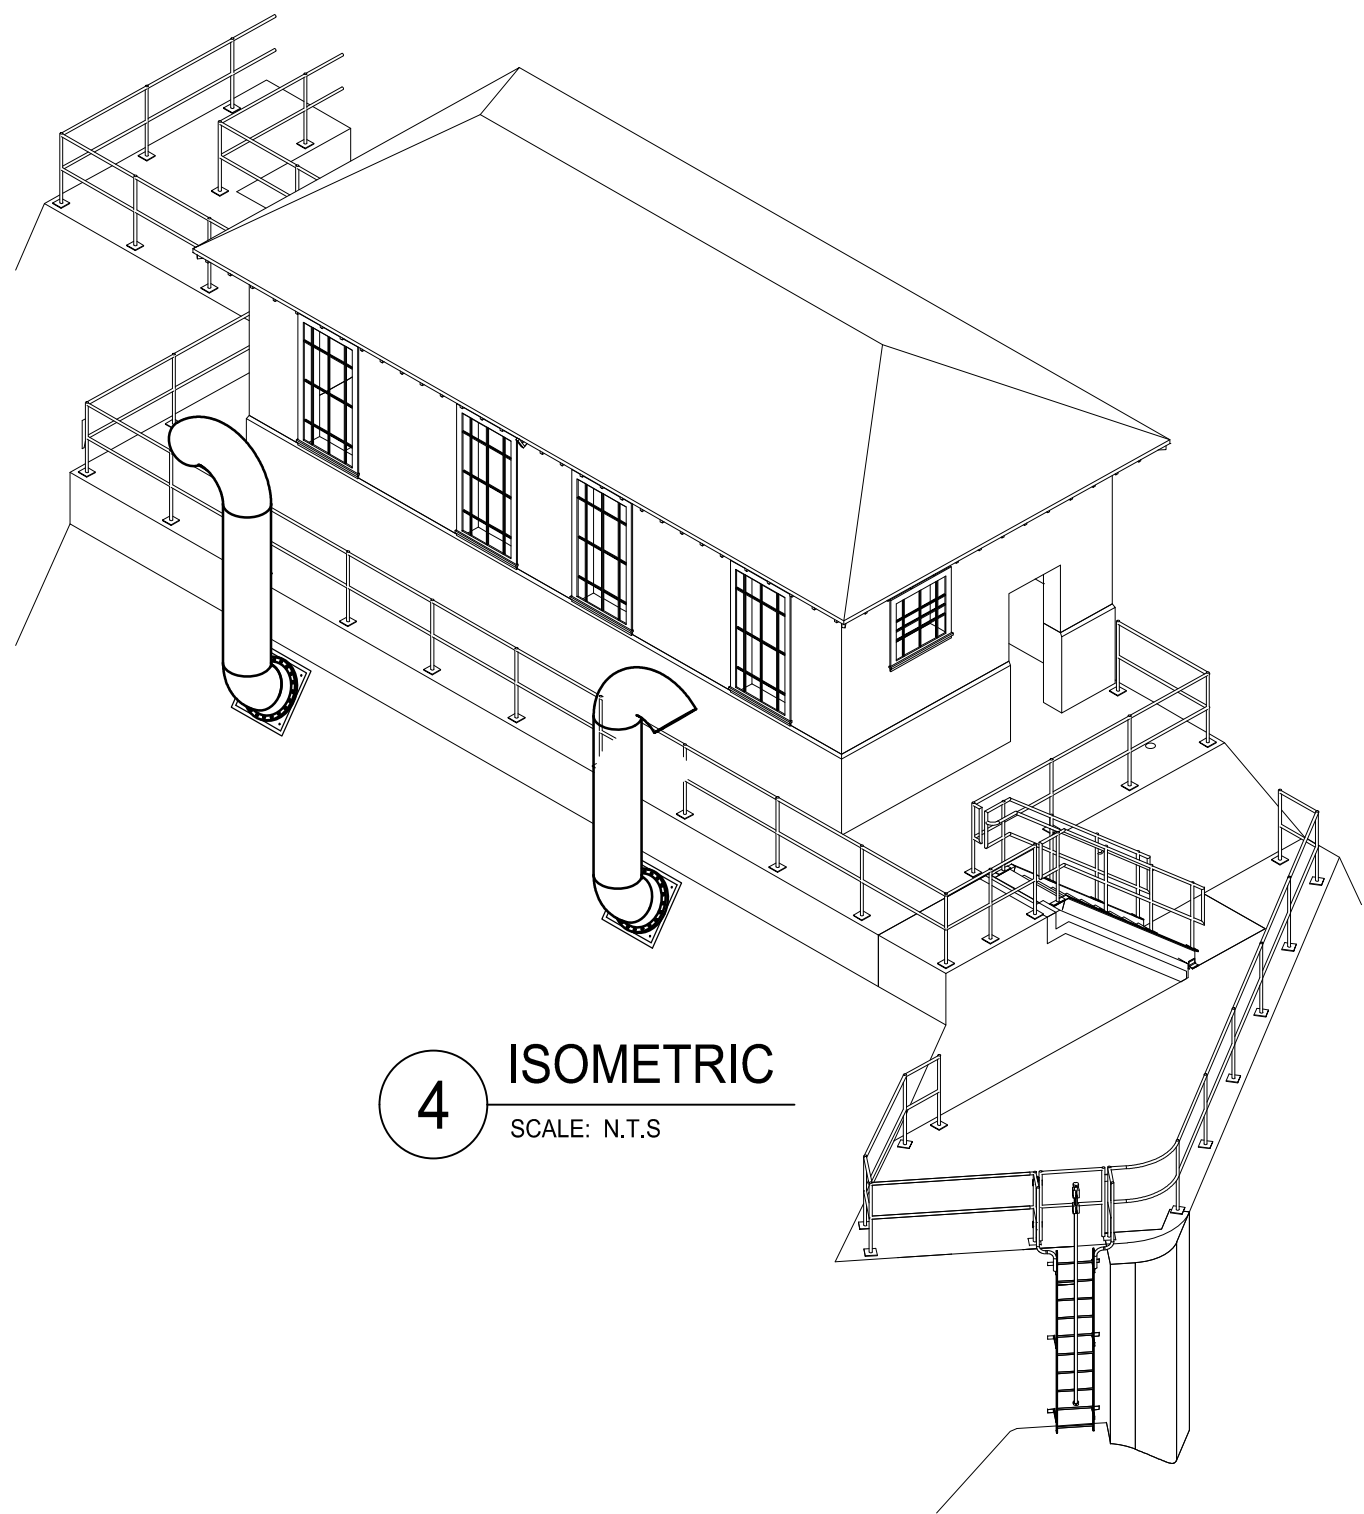

4 ISOMETRIC
SCALE: N.T.S

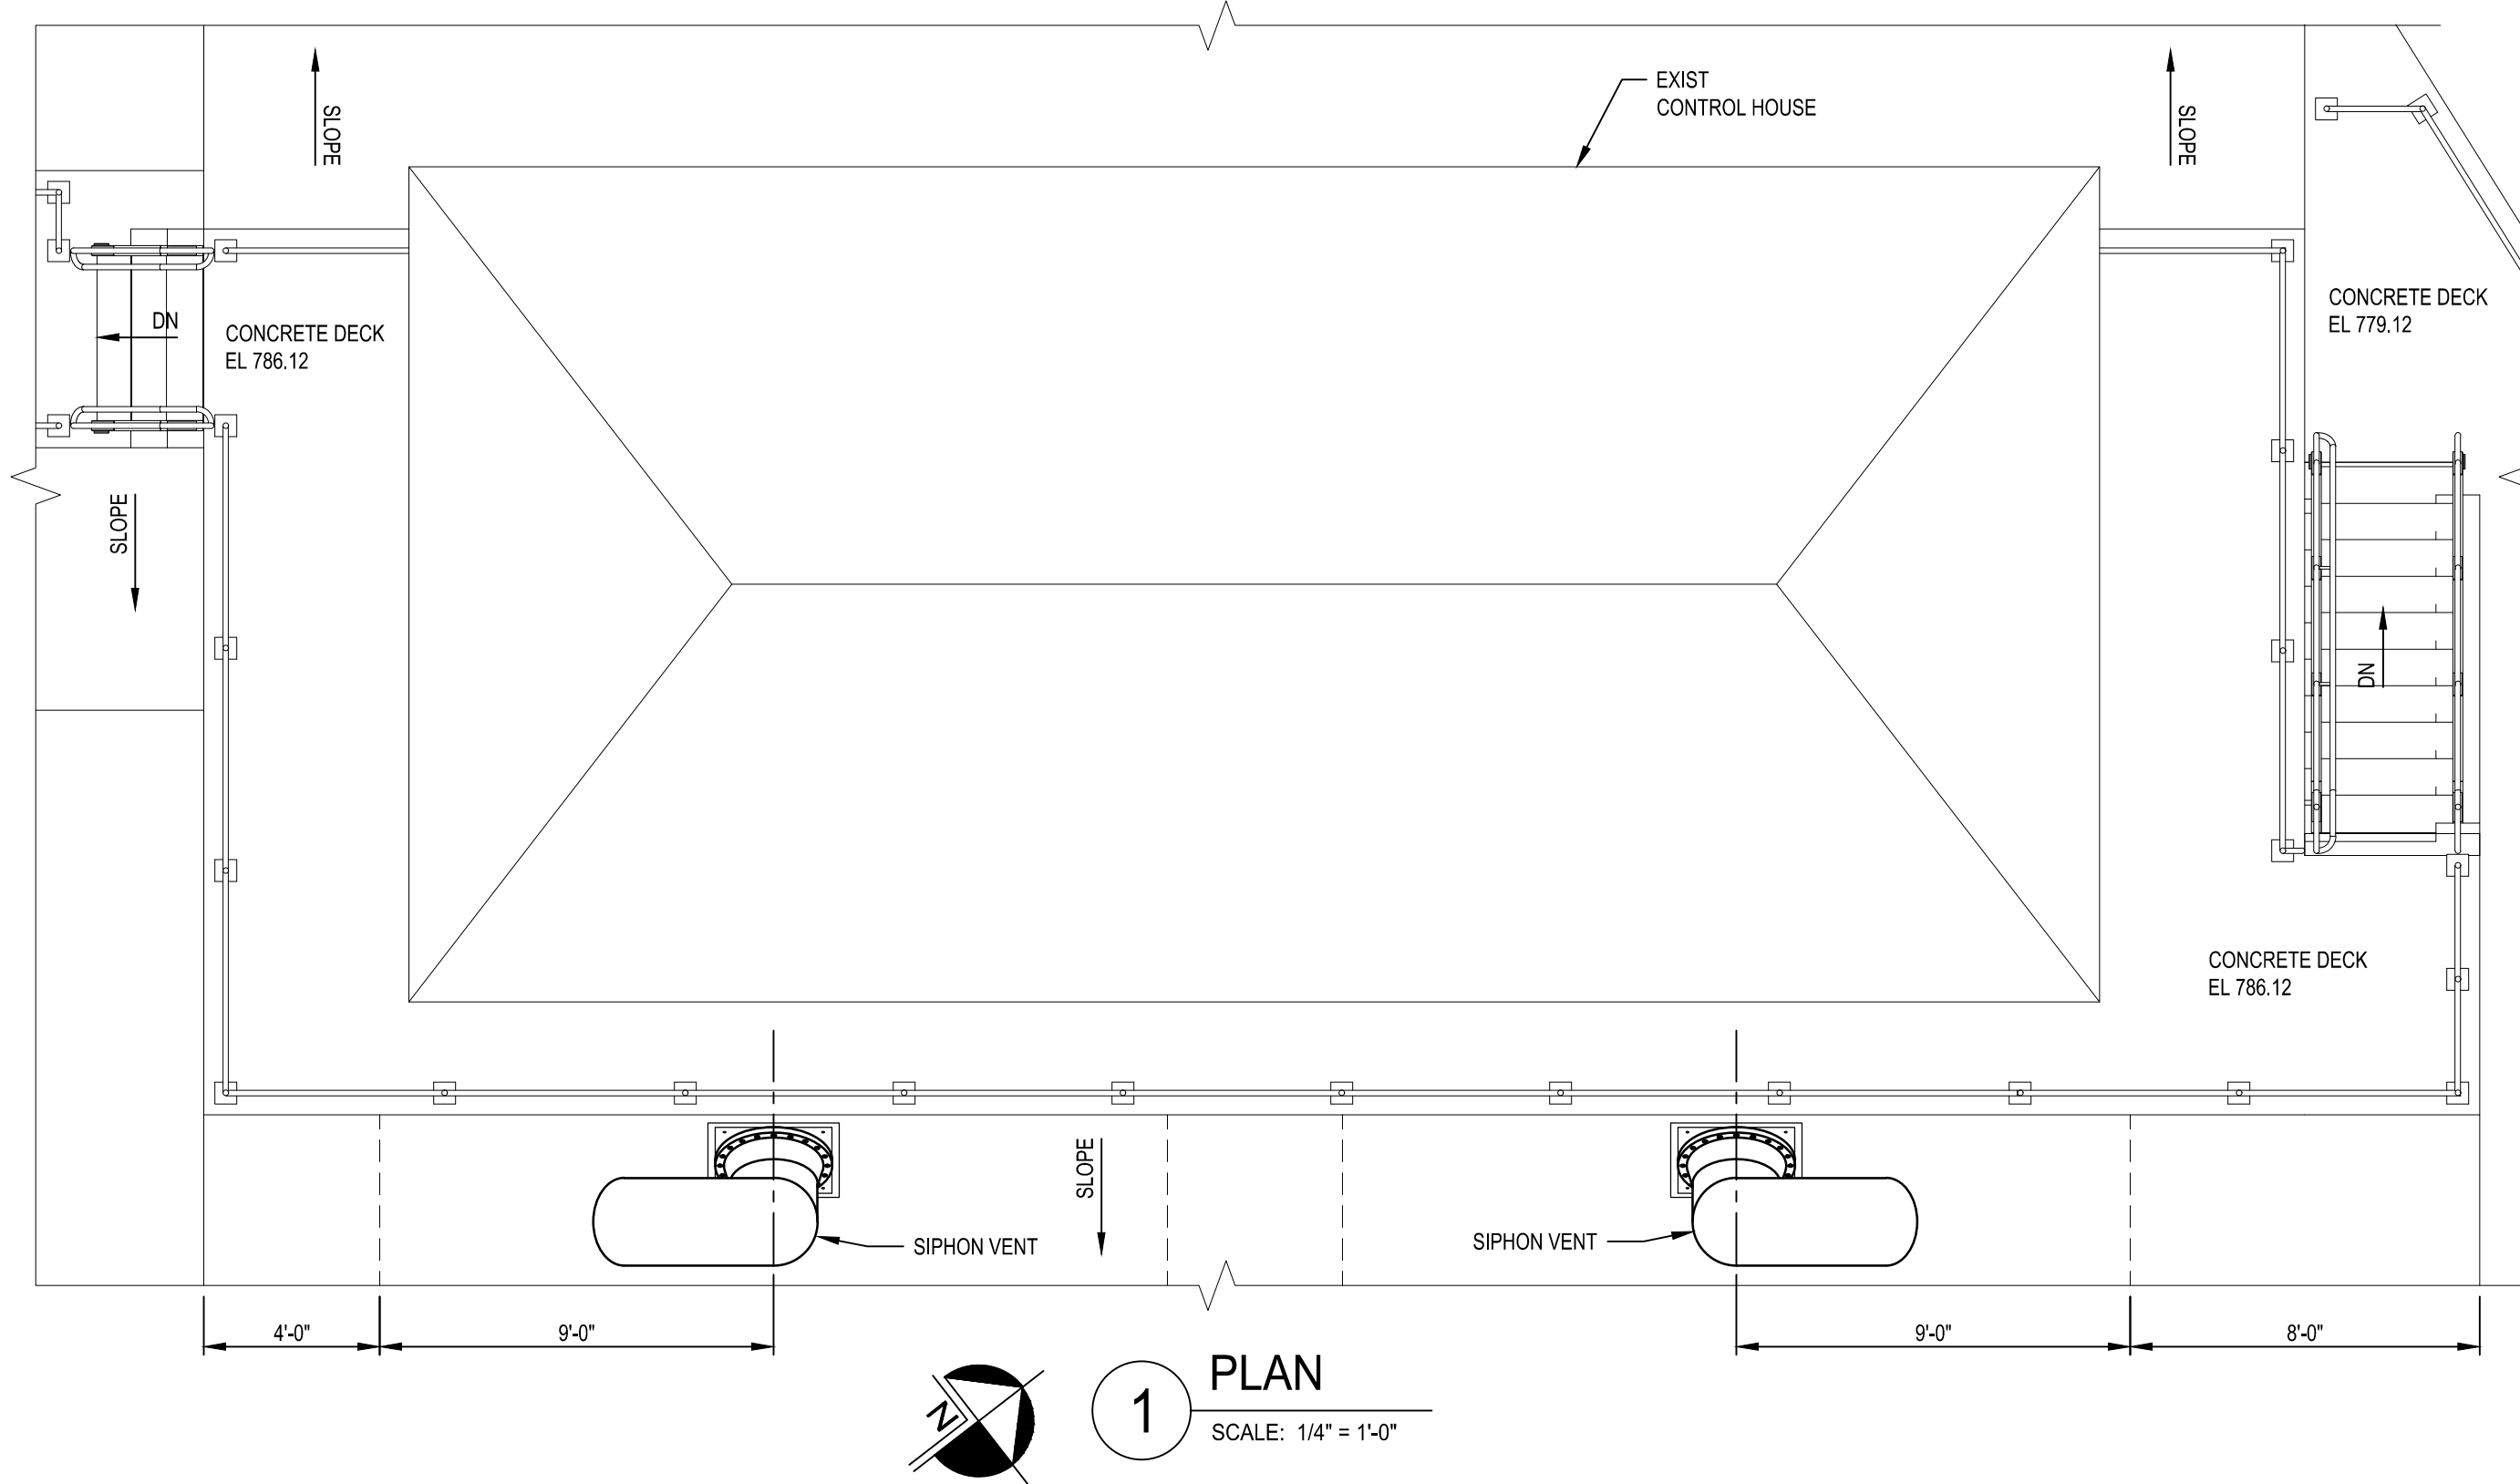


1 PLAN
SCALE: 1/4" = 1'-0"


DRAWING NOTES

1. SEE DRAWINGS G-003 & G-004 FOR ADDITIONAL NOTES.


LEGEND	
	EXISTING CONCRETE (SECTION)
	LIMITS OF CONCRETE PLACEMENT

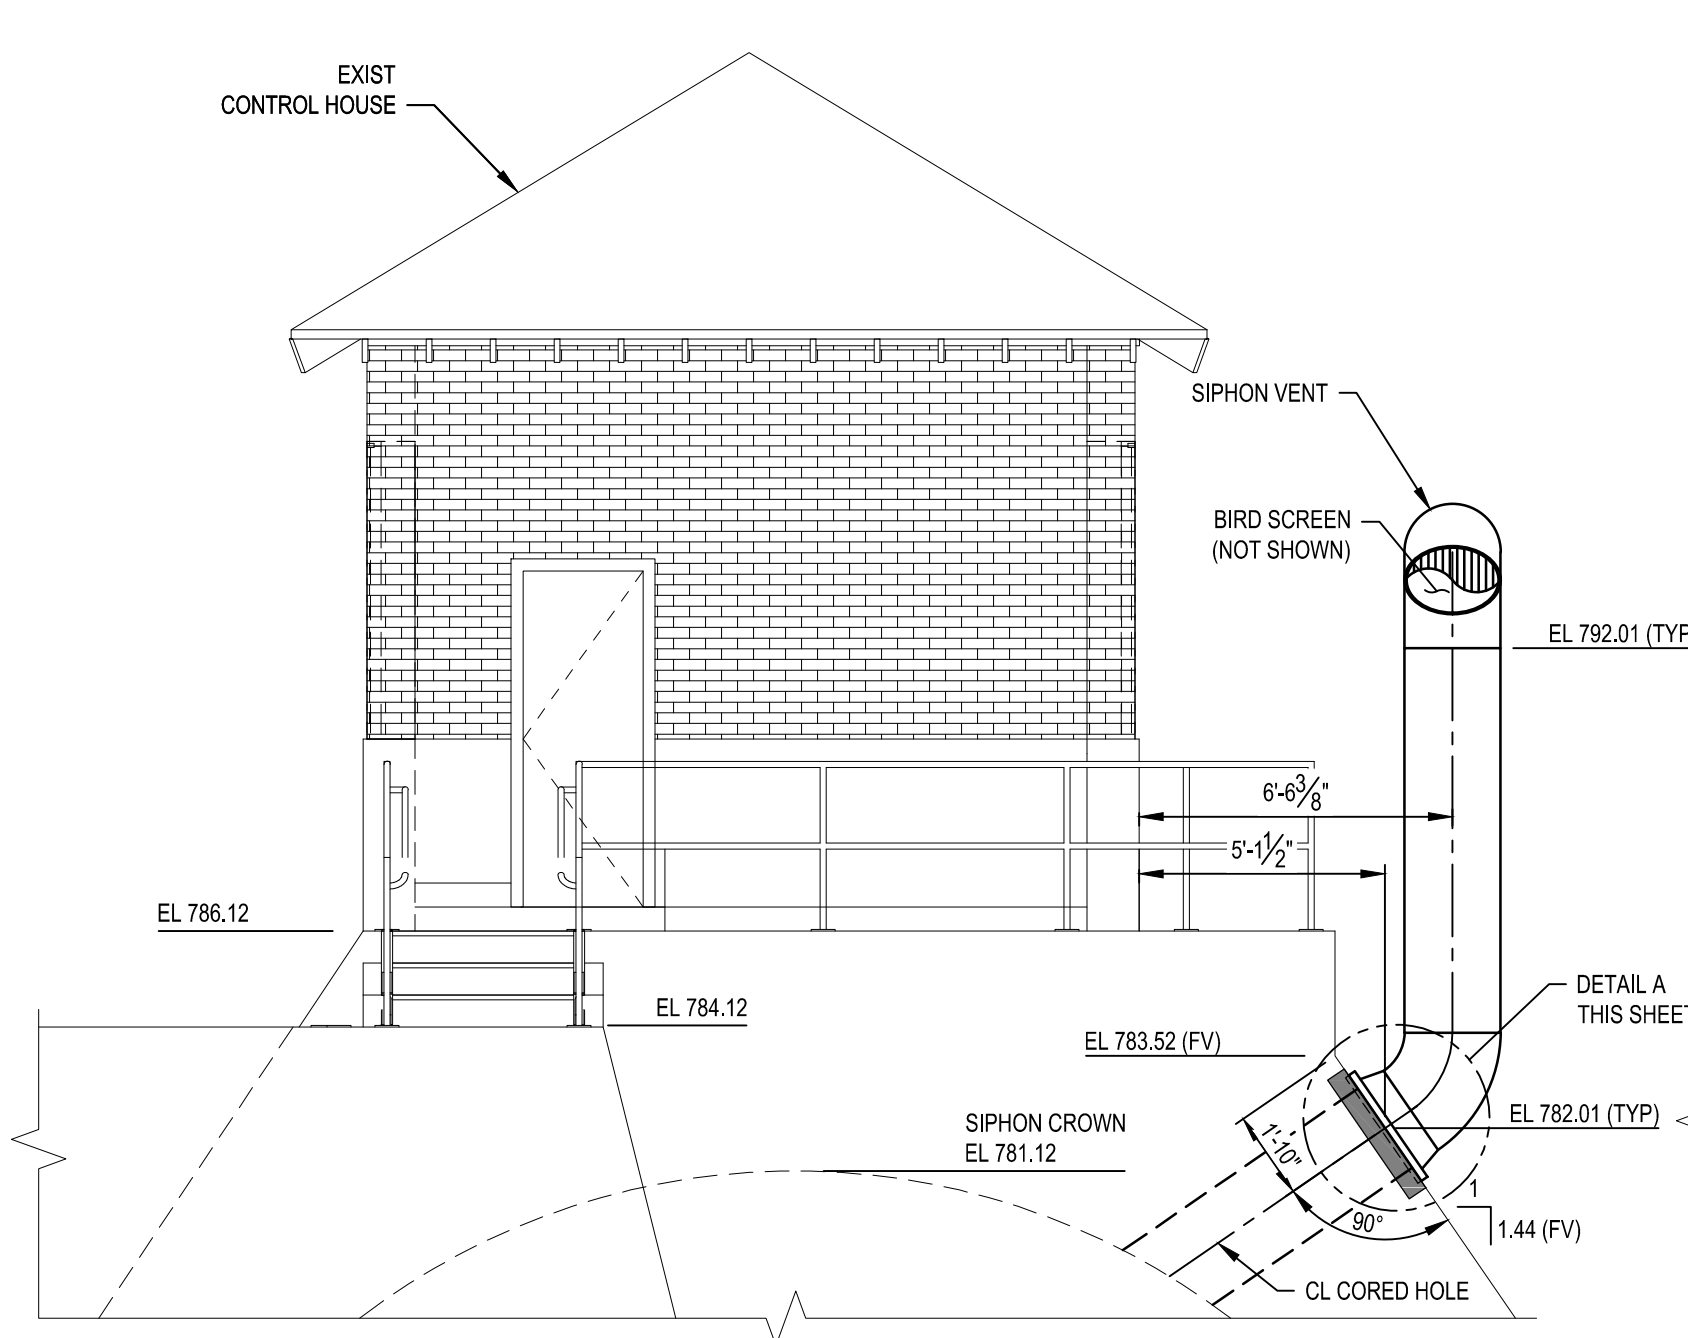


3 WEST ELEVATION
SCALE: 1/4" = 1'-0"

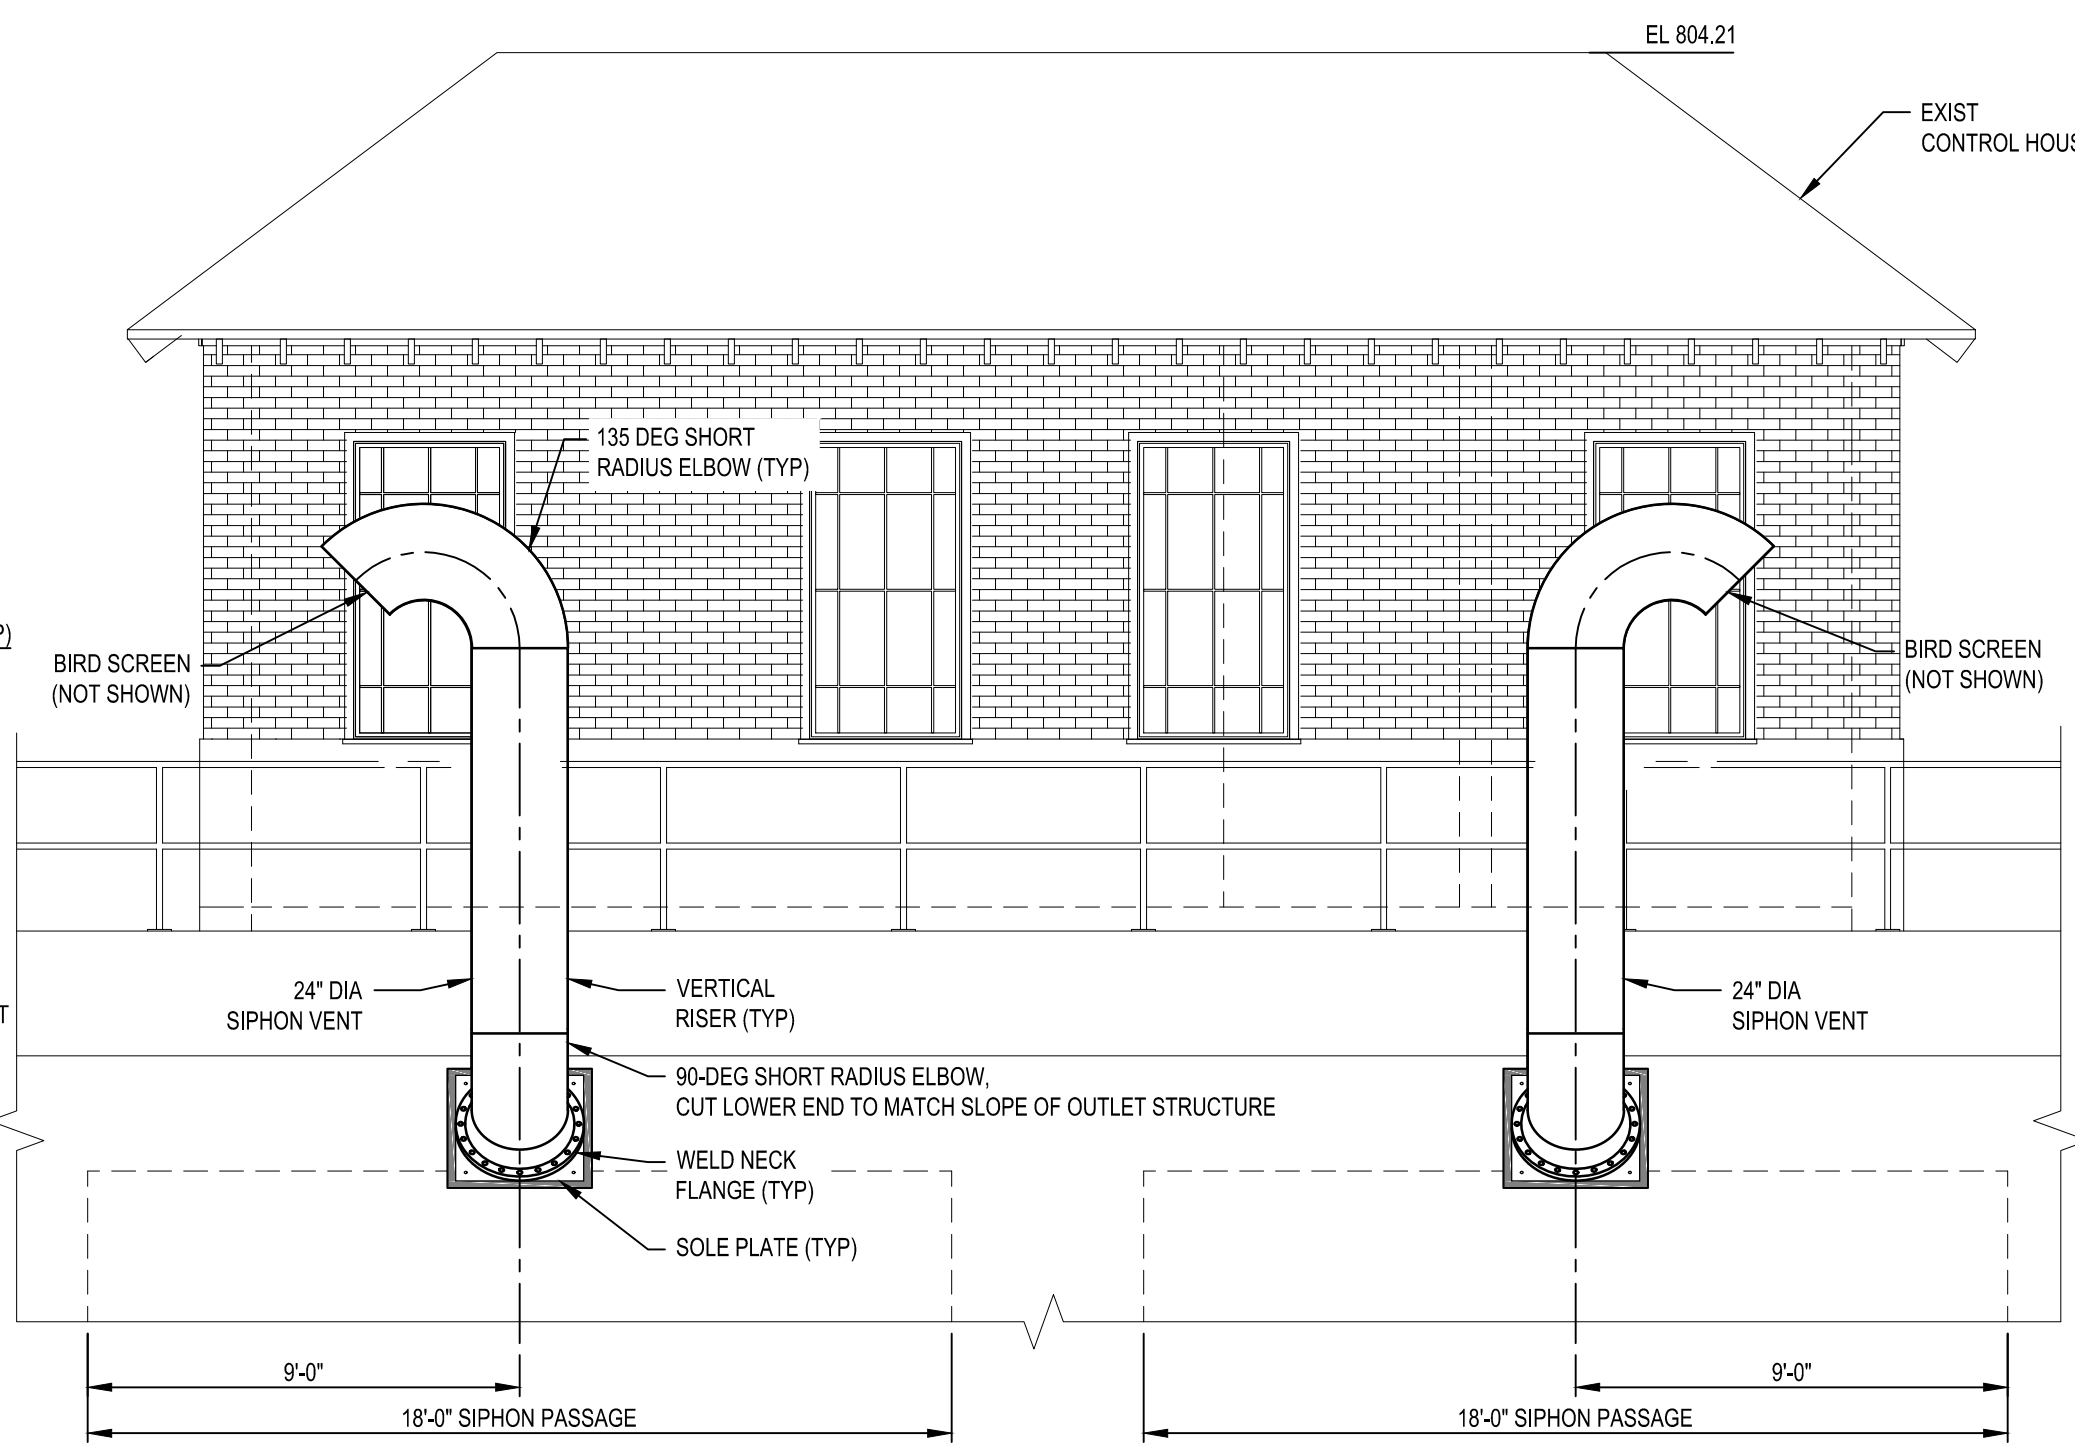


2 DOWNSTREAM ELEVATION
SCALE: 1/4" = 1'-0"

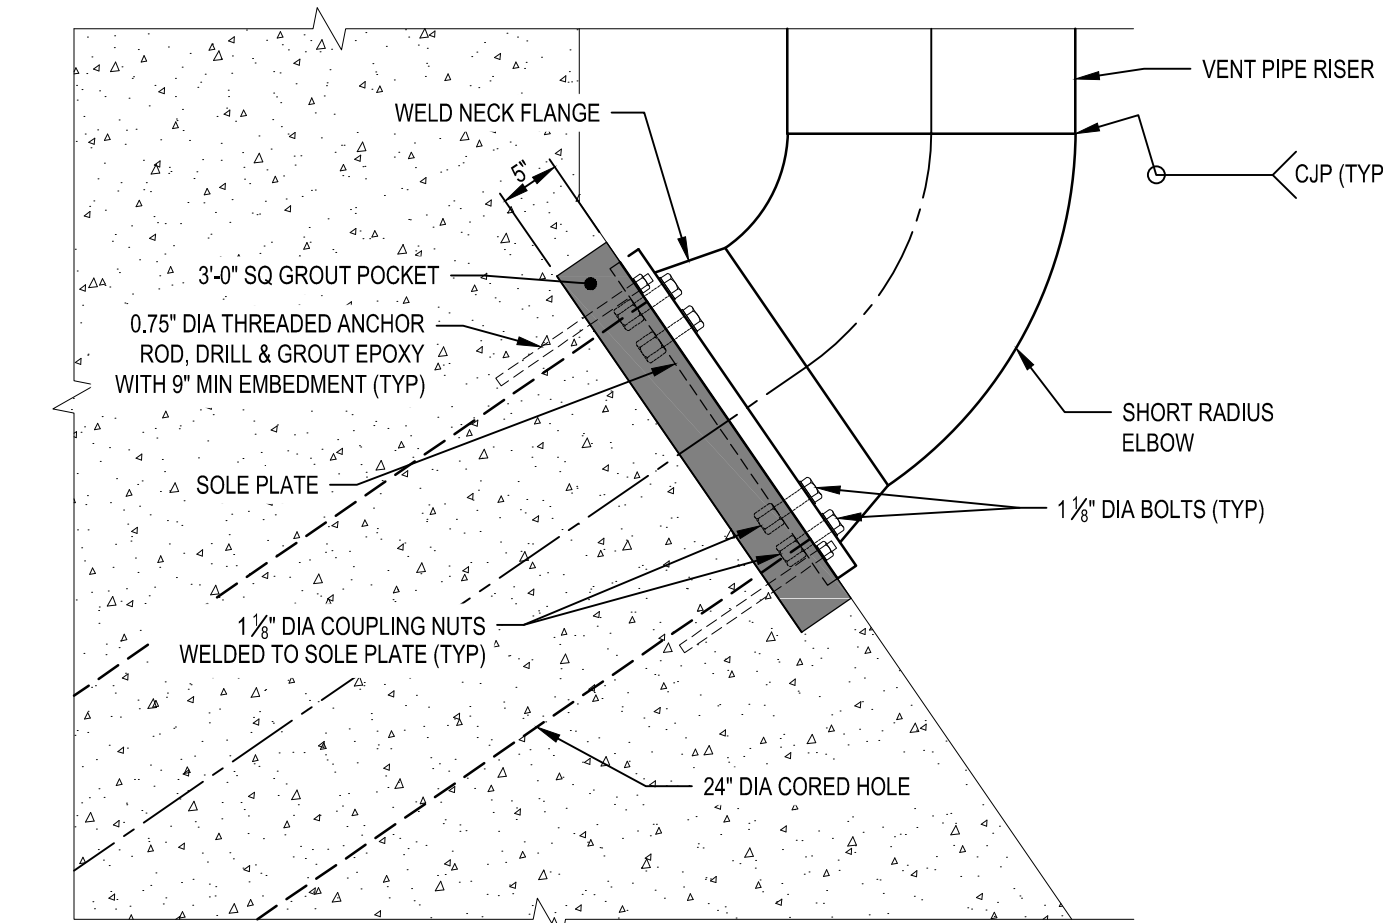


A DETAIL - SIPHON VENT BASE
SCALE: 3/4" = 1'-0"

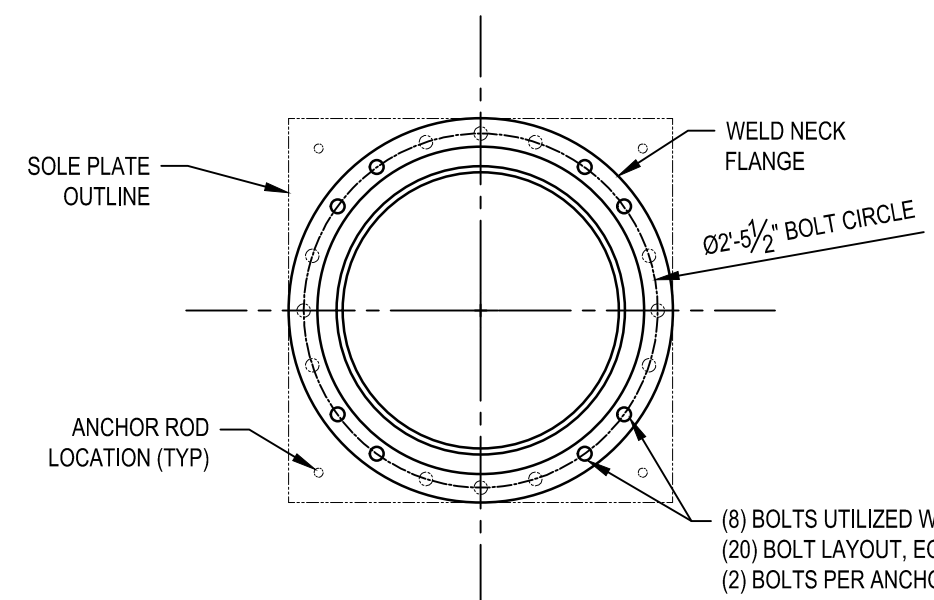

B DETAIL - FLANGE
SCALE: 3/4" = 1'-0"

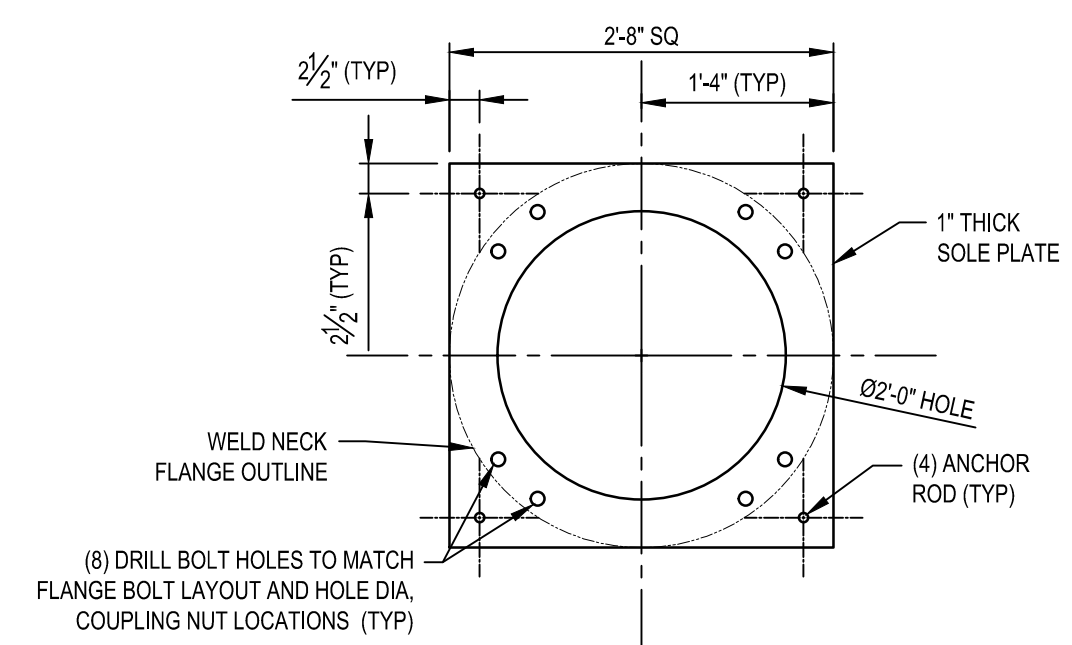

C DETAIL - SOLE PLATE
SCALE: 3/4" = 1'-0"

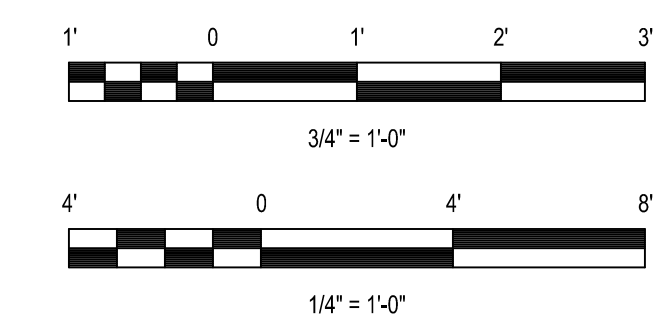

Office of General Services
Department of Environmental Conservation

DESIGN & CONSTRUCTION

CONSULTANT

CERTIFICATE OF AUTHORIZATION #: 0020747

Colliers
Engineering & Design

280 East Broad Street
Suite 200
Rochester, NY 14604
Phone: 585.232.5135
COLLIERS ENGINEERING & DESIGN CT, P.C.
www.colliersengineering.com

UNIFORM CODE STATEMENT:

TO THE BEST OF THE REGISTERED DESIGN PROFESSIONAL'S KNOWLEDGE, BELIEF, AND PROFESSIONAL JUDGEMENT THESE PLANS AND/OR SPECIFICATIONS ARE IN COMPLIANCE WITH THE 2025 UNIFORM CODE.

ENERGY CODE STATEMENT:

TO THE BEST OF THE REGISTERED DESIGN PROFESSIONAL'S KNOWLEDGE, BELIEF, AND PROFESSIONAL JUDGEMENT THESE PLANS AND/OR SPECIFICATIONS ARE IN COMPLIANCE WITH THE 2025 ENERGY CODE.

WARNING:

THE ALTERATION OF THIS MATERIAL IN ANY WAY, UNLESS DONE UNDER THE DIRECTION OF A COMPARABLE PROFESSIONAL, I.E. ARCHITECT FOR AN ARCHITECT, ENGINEER FOR AN ENGINEER OR LANDSCAPE ARCHITECT FOR A LANDSCAPE ARCHITECT, IS A VIOLATION OF THE NEW YORK STATE EDUCATION LAW AND/OR REGULATIONS AND IS A CLASS 'A' MISDEMEANOR.

REGISTRATION EXPIRES: 04/30/2028

CONTRACT:

CONSTRUCTION

TITLE:

PROVIDE FOUNDATION
REMEDATION AND CONCRETE
REPAIR CONKLINGVILLE DAM
NYS DAM ID #205-0415

LOCATION:

233 COUNTY ROUTE 8
HADLEY, NY
SARATOGA COUNTY

CLIENT:

NYS DEPARTMENT OF
ENVIRONMENTAL CONSERVATION

BID DOCUMENTS

1	07/13/2026	ADDENDUM #1 ADDED P.E. STAMP
0	06/22/2026	BID DOCUMENTS
MARK	DATE	DESCRIPTION

PROJECT NUMBER: 47164-C

DESIGNED BY: RCP

DRAWN BY: MDI

FIELD CHECK: -

APPROVED: JMR

SHEET TITLE:

METALS
SIPHON VENT PIPING
PLAN & ELEVATIONS

DRAWING NUMBER:

S-791

SHEET 118 OF 148